



ISO A1 594mm x 841mm


Project Management Initials: Designer: JC Checked: CK Approved: DB

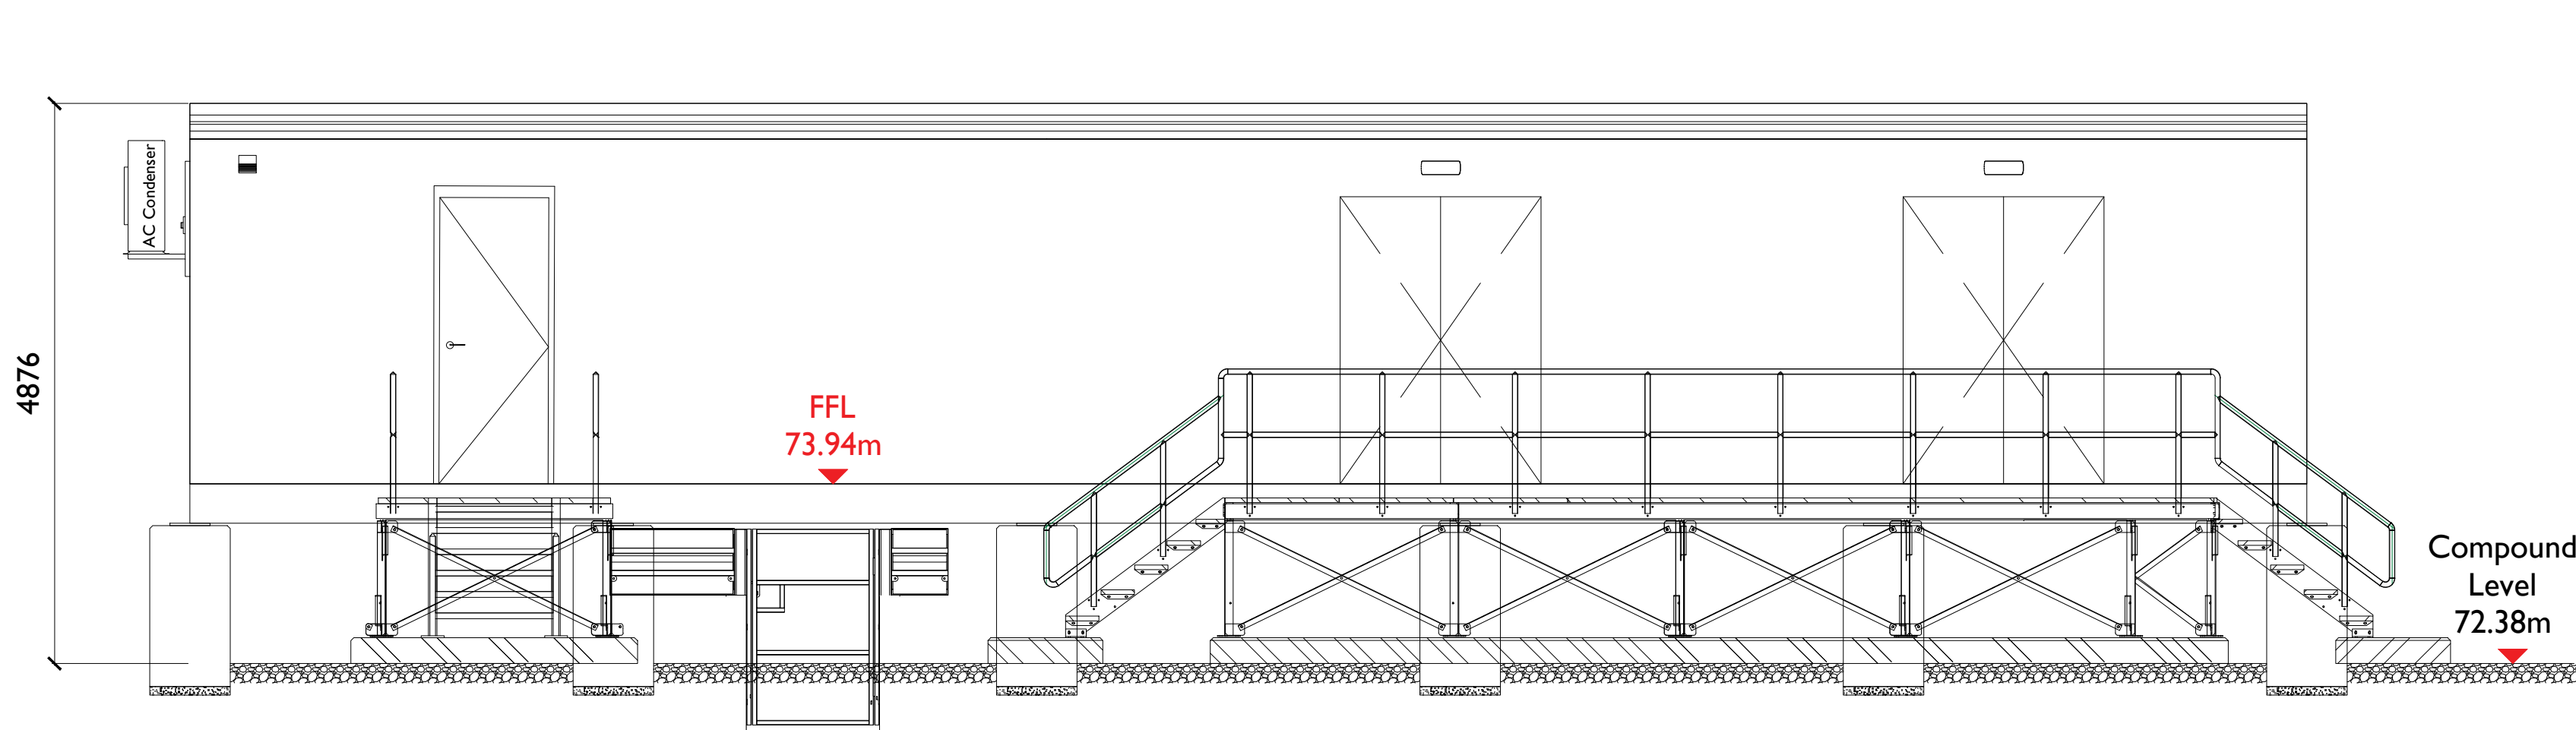

Front View (West Elevation D-D)
SCALE 1:50

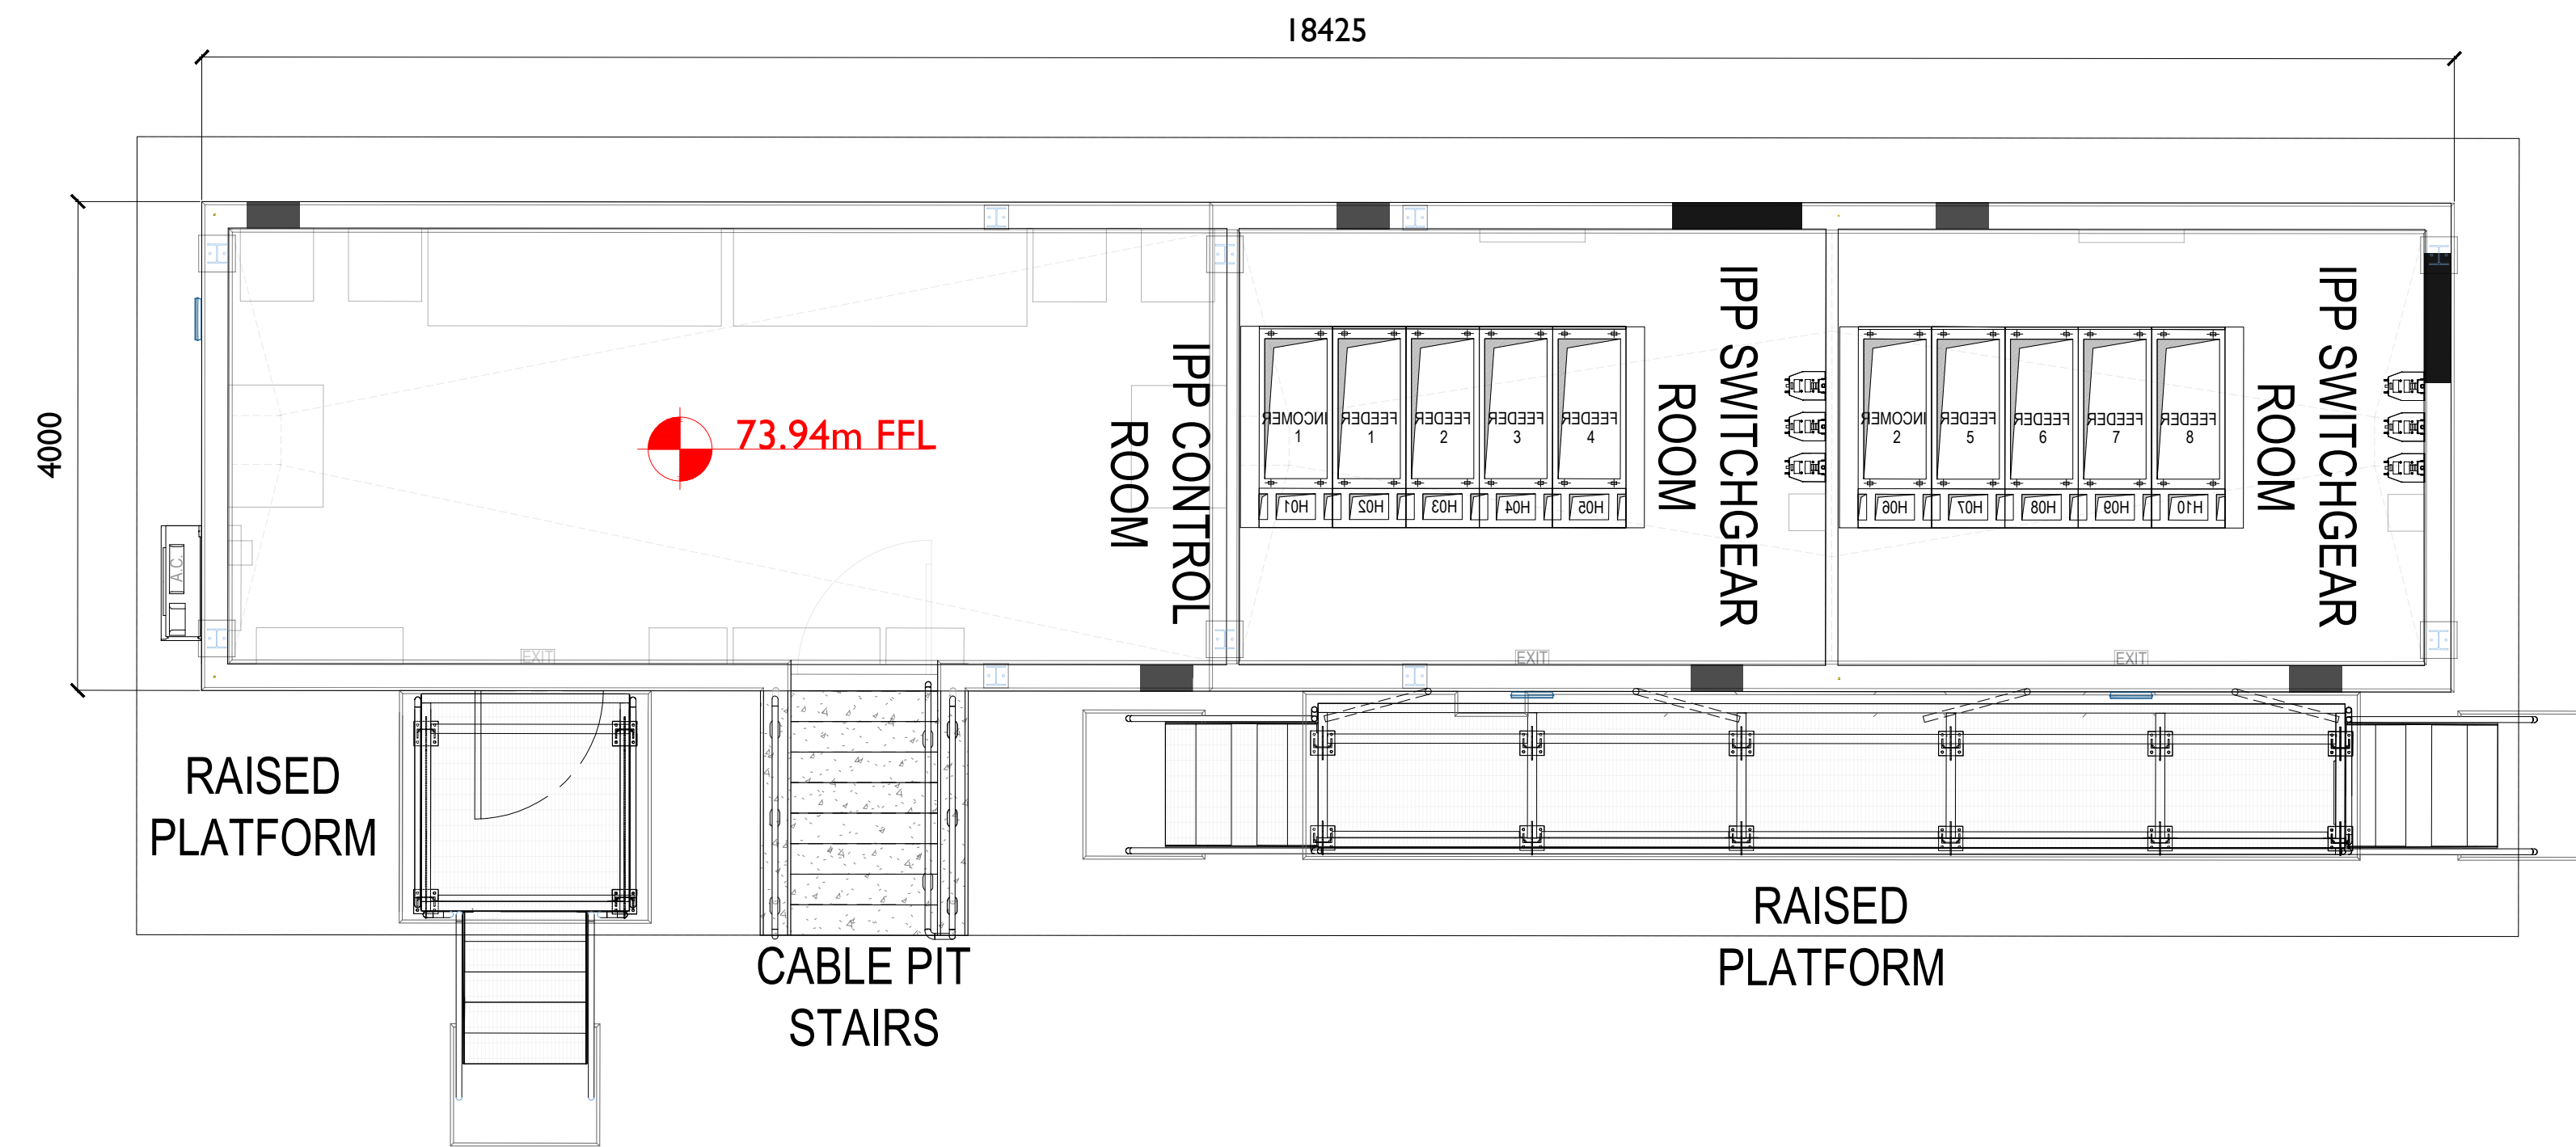

Plan View (MV Customer Building)
SCALE 1:50

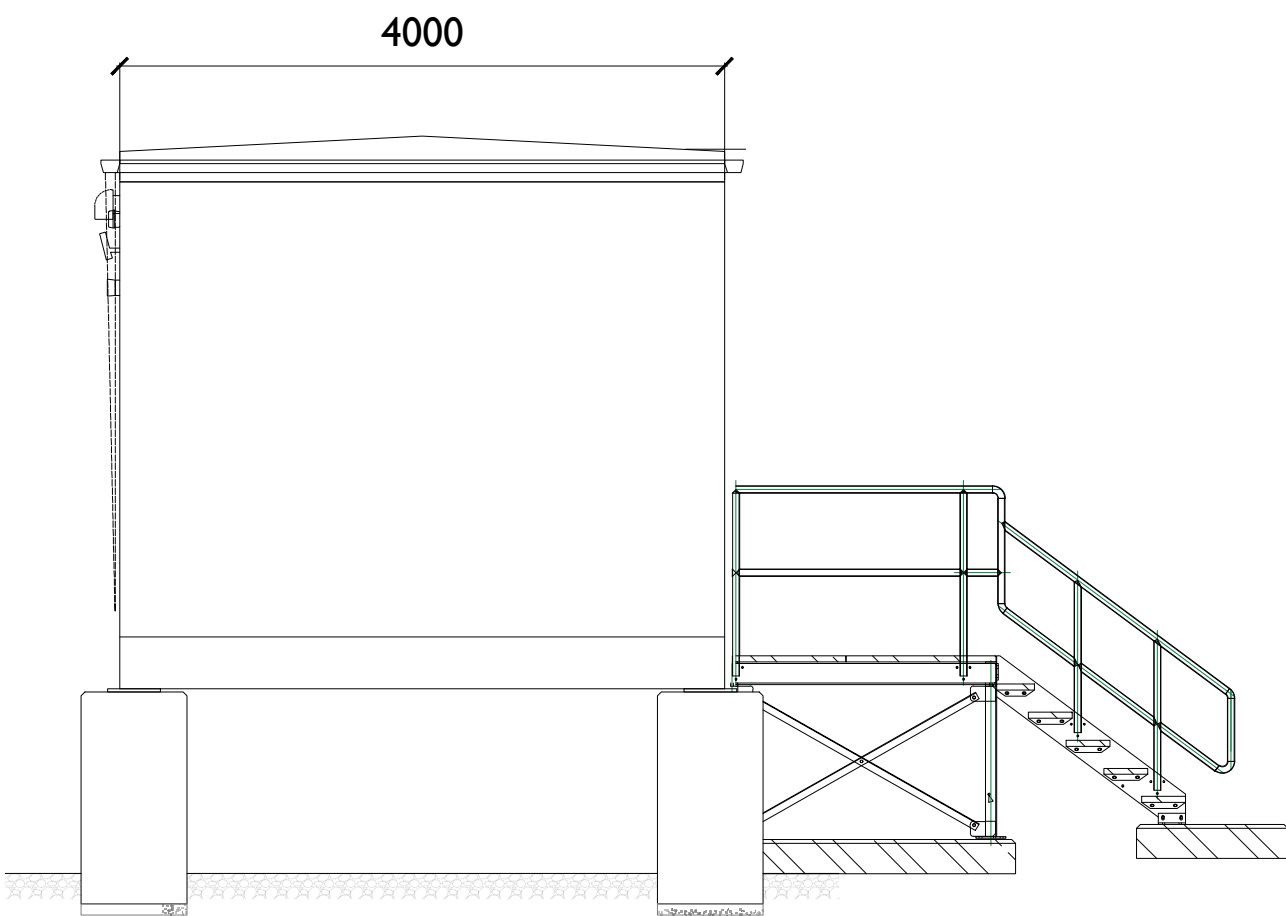

Side View (South Elevation B-B)
SCALE 1:50



Head Office
Beenleigh,
Abbeydorney,
Tralee, Co. Kerry
Ireland
Tel: 00353 66 7135710

Regional Office
Basepoint Business Centre
Stroudley Road, Basingstoke,
Hampshire,
RG24 8UP, UK
Tel: 00 44 1256406664

PROJECT

**Colehill 110kV
Substation**

CLIENT



CONSULTANTS

NOTES: -

1. Layout and Arrangements of Substation Building and Electrical Equipment is shown indicatively and for illustration purposes only.
2. Dimensions shown are as per current EirGrid Specifications at the time of submission. Dimensions may vary at time of construction to reflect any revisions to EirGrid Specifications.
3. Final Specifications of Buildings and Electrical Equipment is to be as per Eirgrid and ESB Specifications.
4. The Elevation of the Compound will be depicted by localized Topography such that Cut/Fill Earthworks associated with the construction of the Compound are balanced.

LEGEND: -

ISSUE/REVISION

| P6 | 07.11.25 | Issue for Planning |
|-----|----------|--------------------------|
| P5 | 23.10.25 | Final Issue for Planning |
| P4 | 19.09.25 | Issued for Planning |
| P3 | 10.02.25 | Issued for Planning |
| P2 | 05.11.24 | Issued for Planning |
| P1 | 21.10.24 | Issued for Client Review |
| I/R | DATE | DESCRIPTION |

PROJECT NUMBER

05-1064

SHEET TITLE

MV Customer Switchgear Modular Room
Plan and Elevations

SHEET NUMBER

051064-DR-133